

LEGEND


- | | | | |
|--|----------------------------------|--|--------------------------|
| | Exit sign internally illuminated | | Double Socket |
| | Emergency lighting luminaire | | Double Socket with USB |
| | Fire alarm control panel | | Spur outlet |
| | Manual fire alarm call point | | Light Switch |
| | Alarm sounder bell | | Downlighter |
| | Smoke detector | | Extract fan and isolator |
| | Heat detector | | Cooker point |

GENERAL NOTES


- External lighting to be installed at front and back PIR lights on timers
- CCTV electricis to be confirmed with Westrock
- Lighting for Flexible Community Space to be agreed following advice being sought from Lighting Engineer - note some lighting will need to be dimmable
- Contrast light switches and sockets in Flexible Community Space, External and Internal WC's and Kitchen i.e. chrome/silver
- Fire Alarm system required
- Intruder Alarm system required
- Heating is to be agreed following advice from Heating Engineer including frost thermostats
- External WC - Investigate possibility of installing a hidden waste bin in external wall with lockable access door externally for emptying

NOTES:

- THIS DRAWING is copyright 2022 Mullins Dowse Architects
- SETTING OUT all dimensions to structural faces
- SETTING OUT confirm all dimensions on site
- DIMENSIONS OF JOINERY components show actual joinery sizes: the builder must allow tolerances for building in, fitting and jointing
- CONFIRM DIMENSIONS on site for all components prior to manufacture
- REPORT all discrepancies to the clients/architects and obtain their instructions/advice before proceeding
- READ THIS DRAWING in conjunction with the relevant structural engineers drawings
- READ THIS DRAWING in conjunction with the construction notes

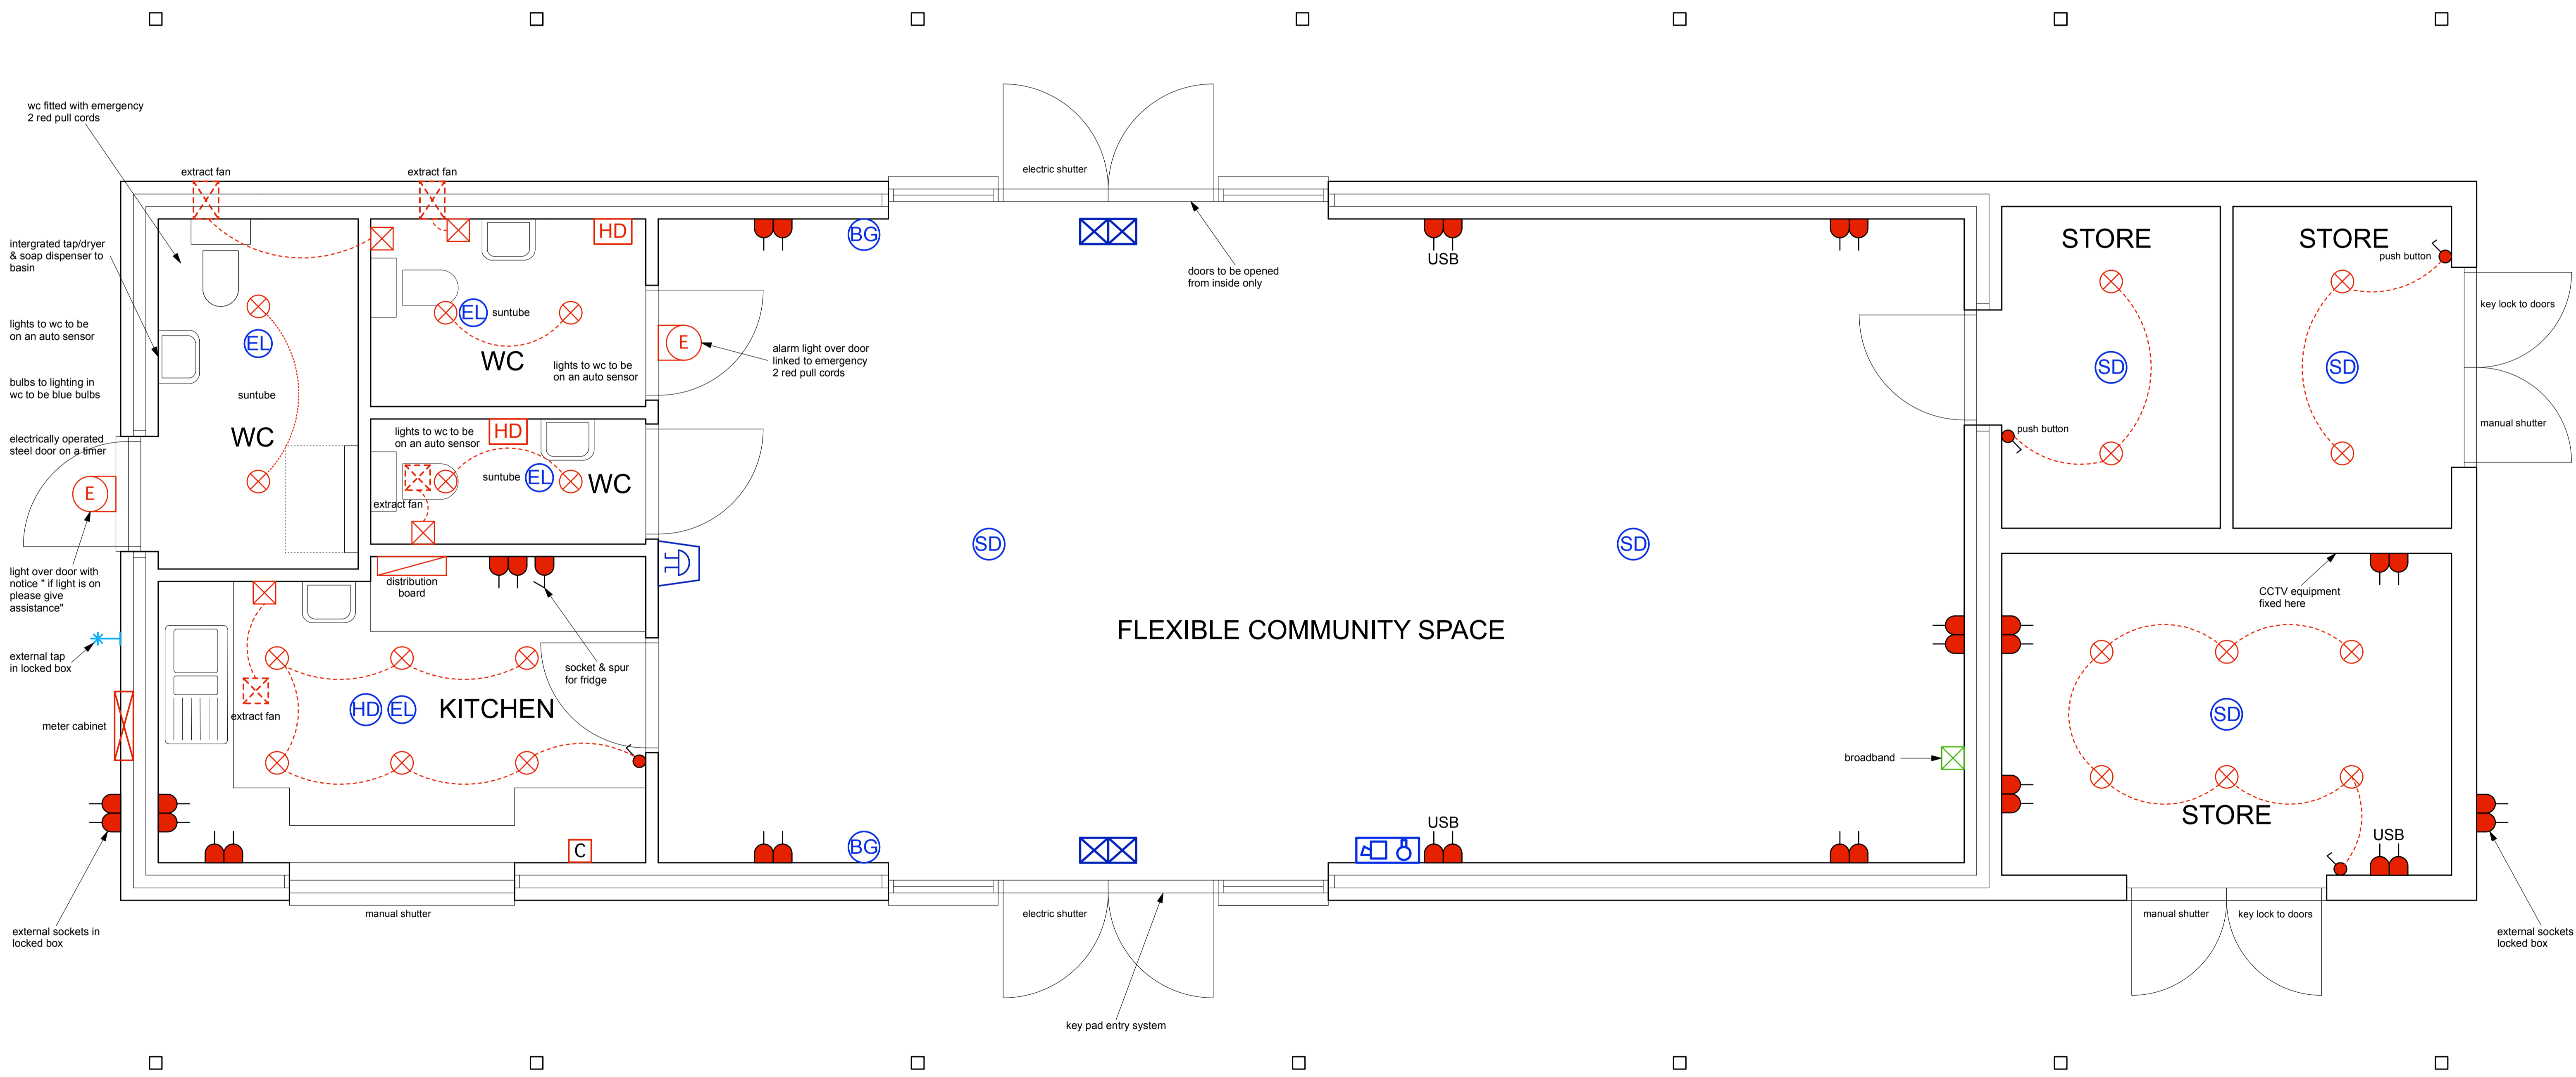

PLAN

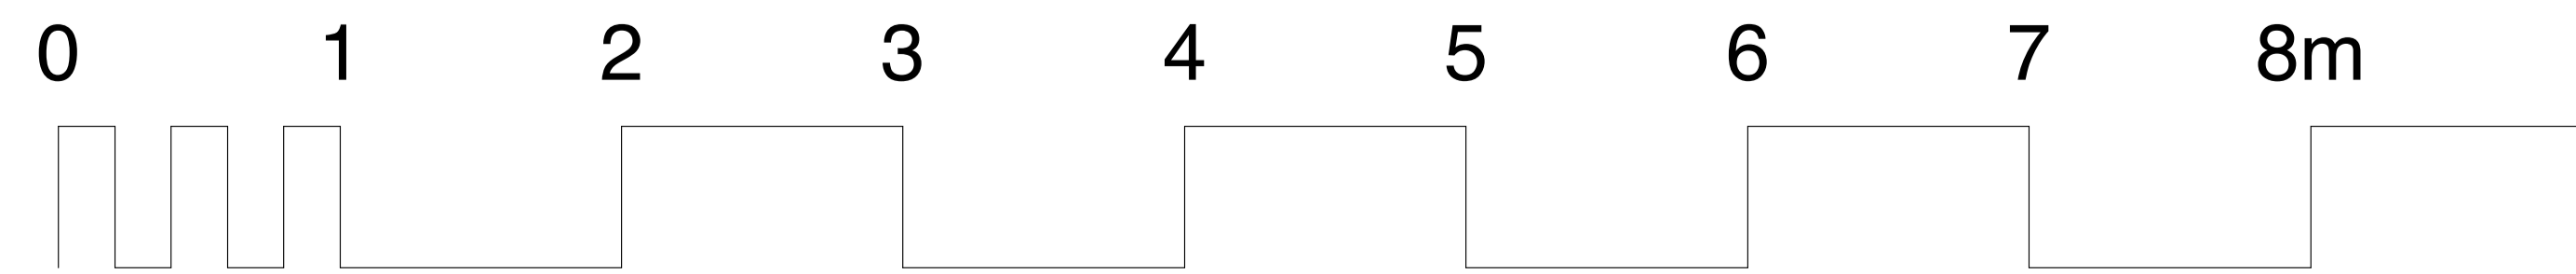

revision	date	description	drawn	checked
A	April 2022	Minor revs and additions		
project Replacement Pavilion At Melton Playing Field, Melton Road, Melton, Woodbridge IP12 1NH.				
drawing Working Drawing Electrical Layout				
date	scale	drawn	checked	
April 2022	1:25 @ A1	AW	AW	
job ref	drawing	revision		
6261	4	A		

MDA
 10A Quay Street, Woodbridge, Suffolk, IP12 1BX
 01394 382544
 www.mullinsdowse.co.uk